


FORUM
CISTERN TANK

STAR CITY

M. JALANDONI ST.

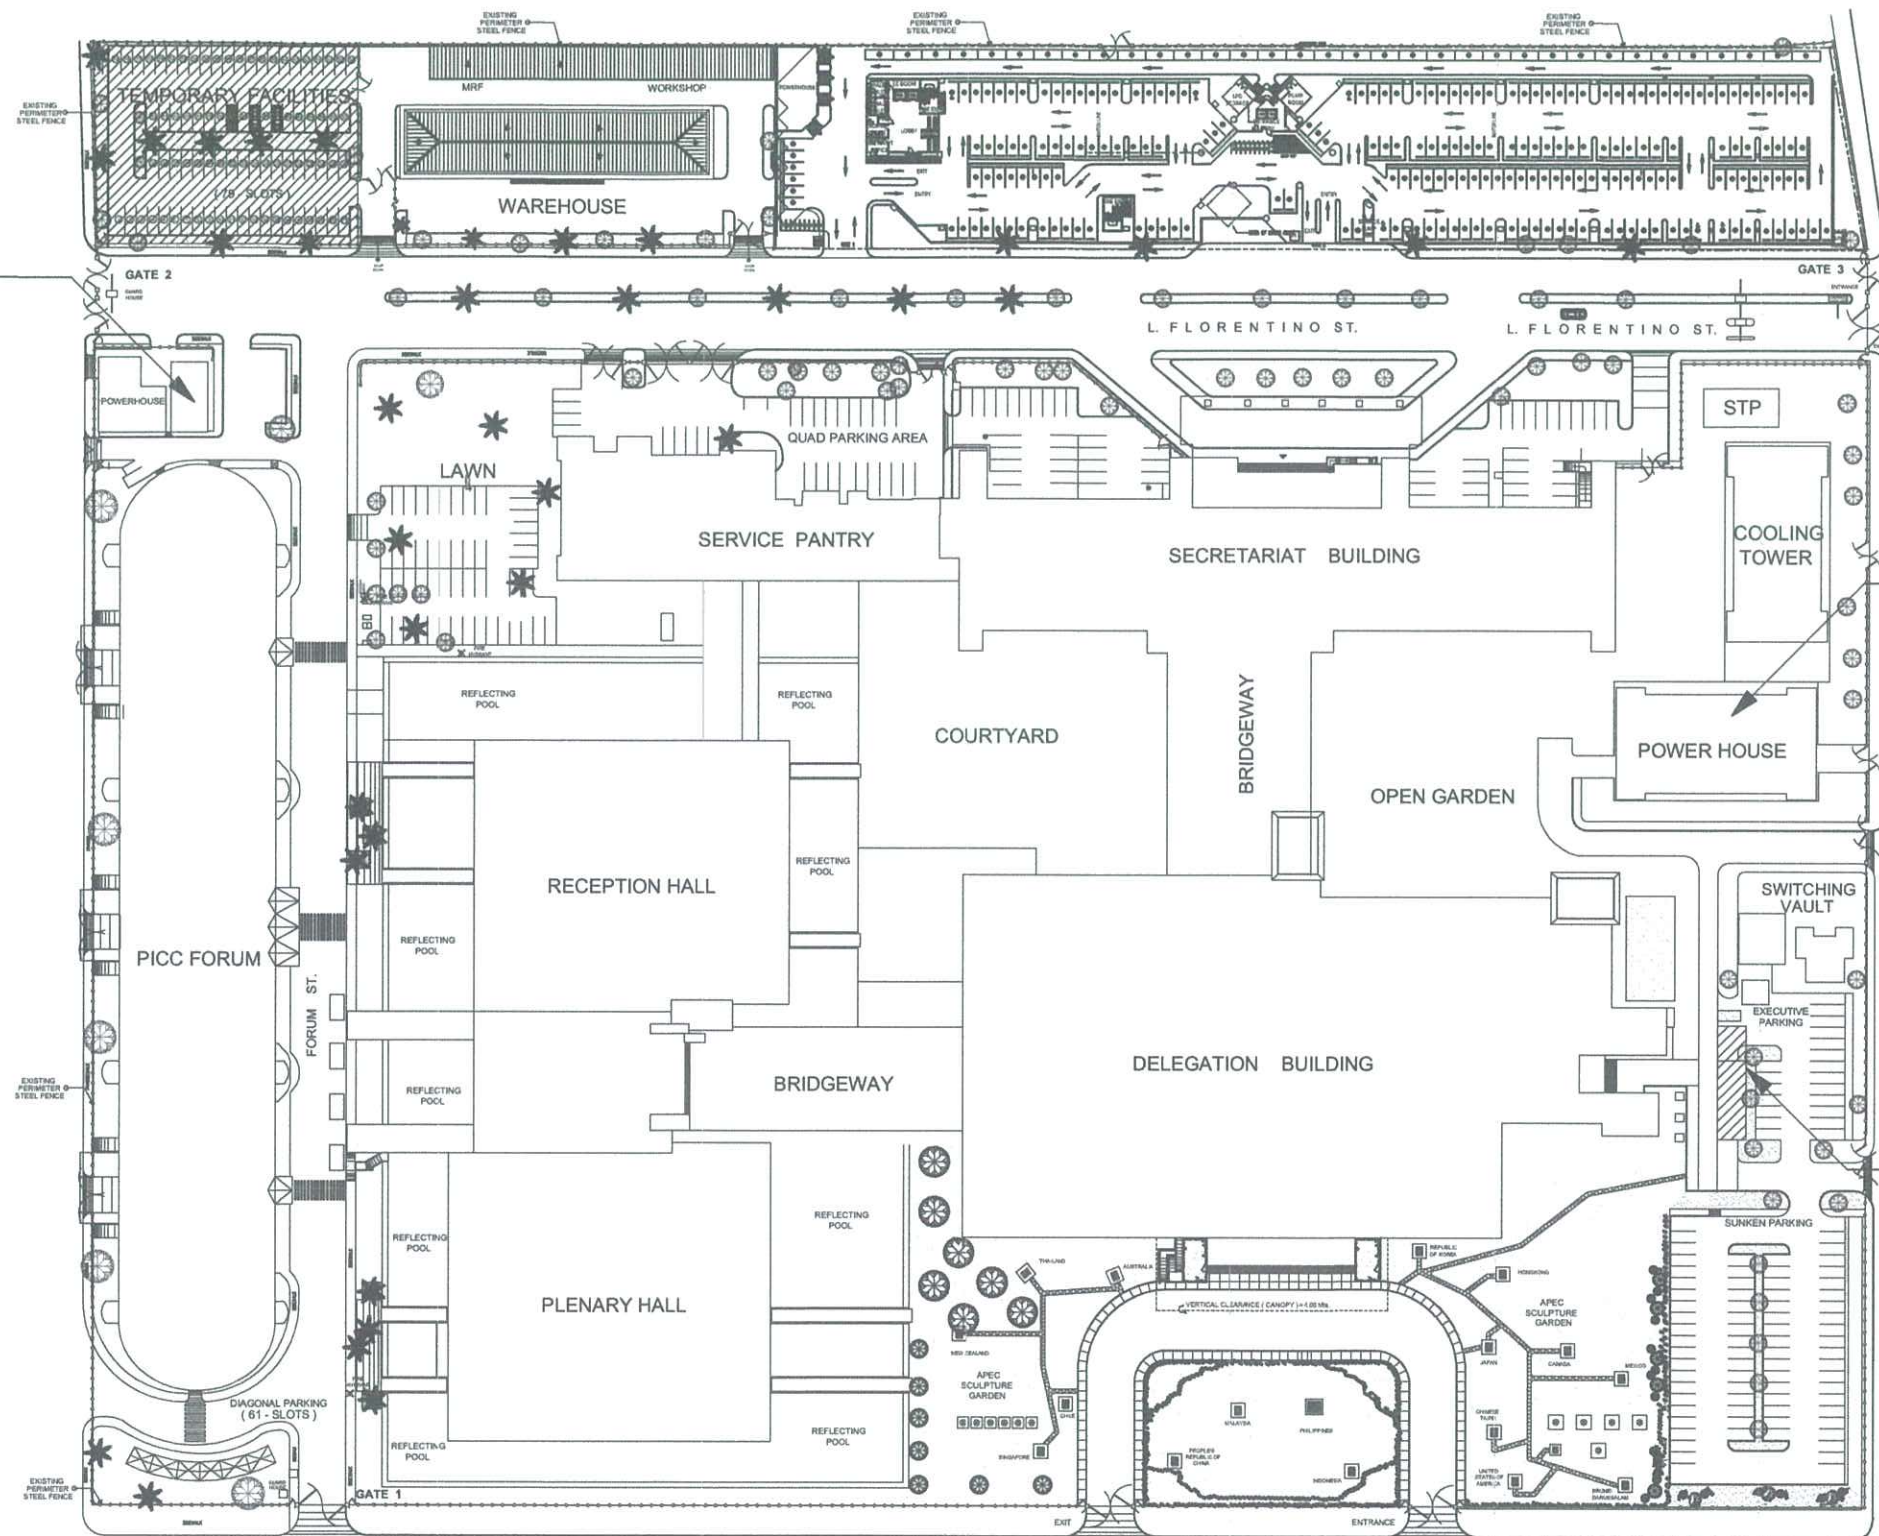

POWER HOUSE
CISTERN TANK

ATANG DELA RAMA ST.

DELEGATION
PARKING
CISTERN TANK

SOFITEL PHILIPPINE PLAZA HOTEL

V. SOTTO ST.

1
A 1 **LOCATION PLAN OF CISTERN TANKS**
SCALE: NTS




TITLE	DATE	REVISION	VERIFIED BY	RECOMMENDING APPROVAL	APPROVED BY	SHEET NO.
SUPPLY OF LABOR AND MATERIALS FOR THE CLEANING OF CISTERN TANKS AT DELEGATION, POWER HOUSE AND FORUM	09.16.2022	12.21.2023	AR. REYNALDO B. MENDOZA JR. BLDG. SERVICES OFFICER	ENGR. WILSON B. DE LOS REYES DIRECTOR, T&D	ATTY. RENATO B. PADILLA GENERAL MANAGER	1
LOCATION	AUTOCAD BY	CHECKED BY				A 6
PICC COMPLEX	LOUIE JAY E. GADON AUTOCAD OPERATOR	ENGR. EDISON T. AURELIO ASSISTANT DIRECTOR, BSD-TSD		MR. ROBERTO A. GARCIA DEPUTY GENERAL MANAGER		

146d

REPAINTING & APPLICATION
OF SEALANT

REPAINTING OF THE
STEEL PLATE COVER

REPAINTING & APPLICATION
OF SEALANT

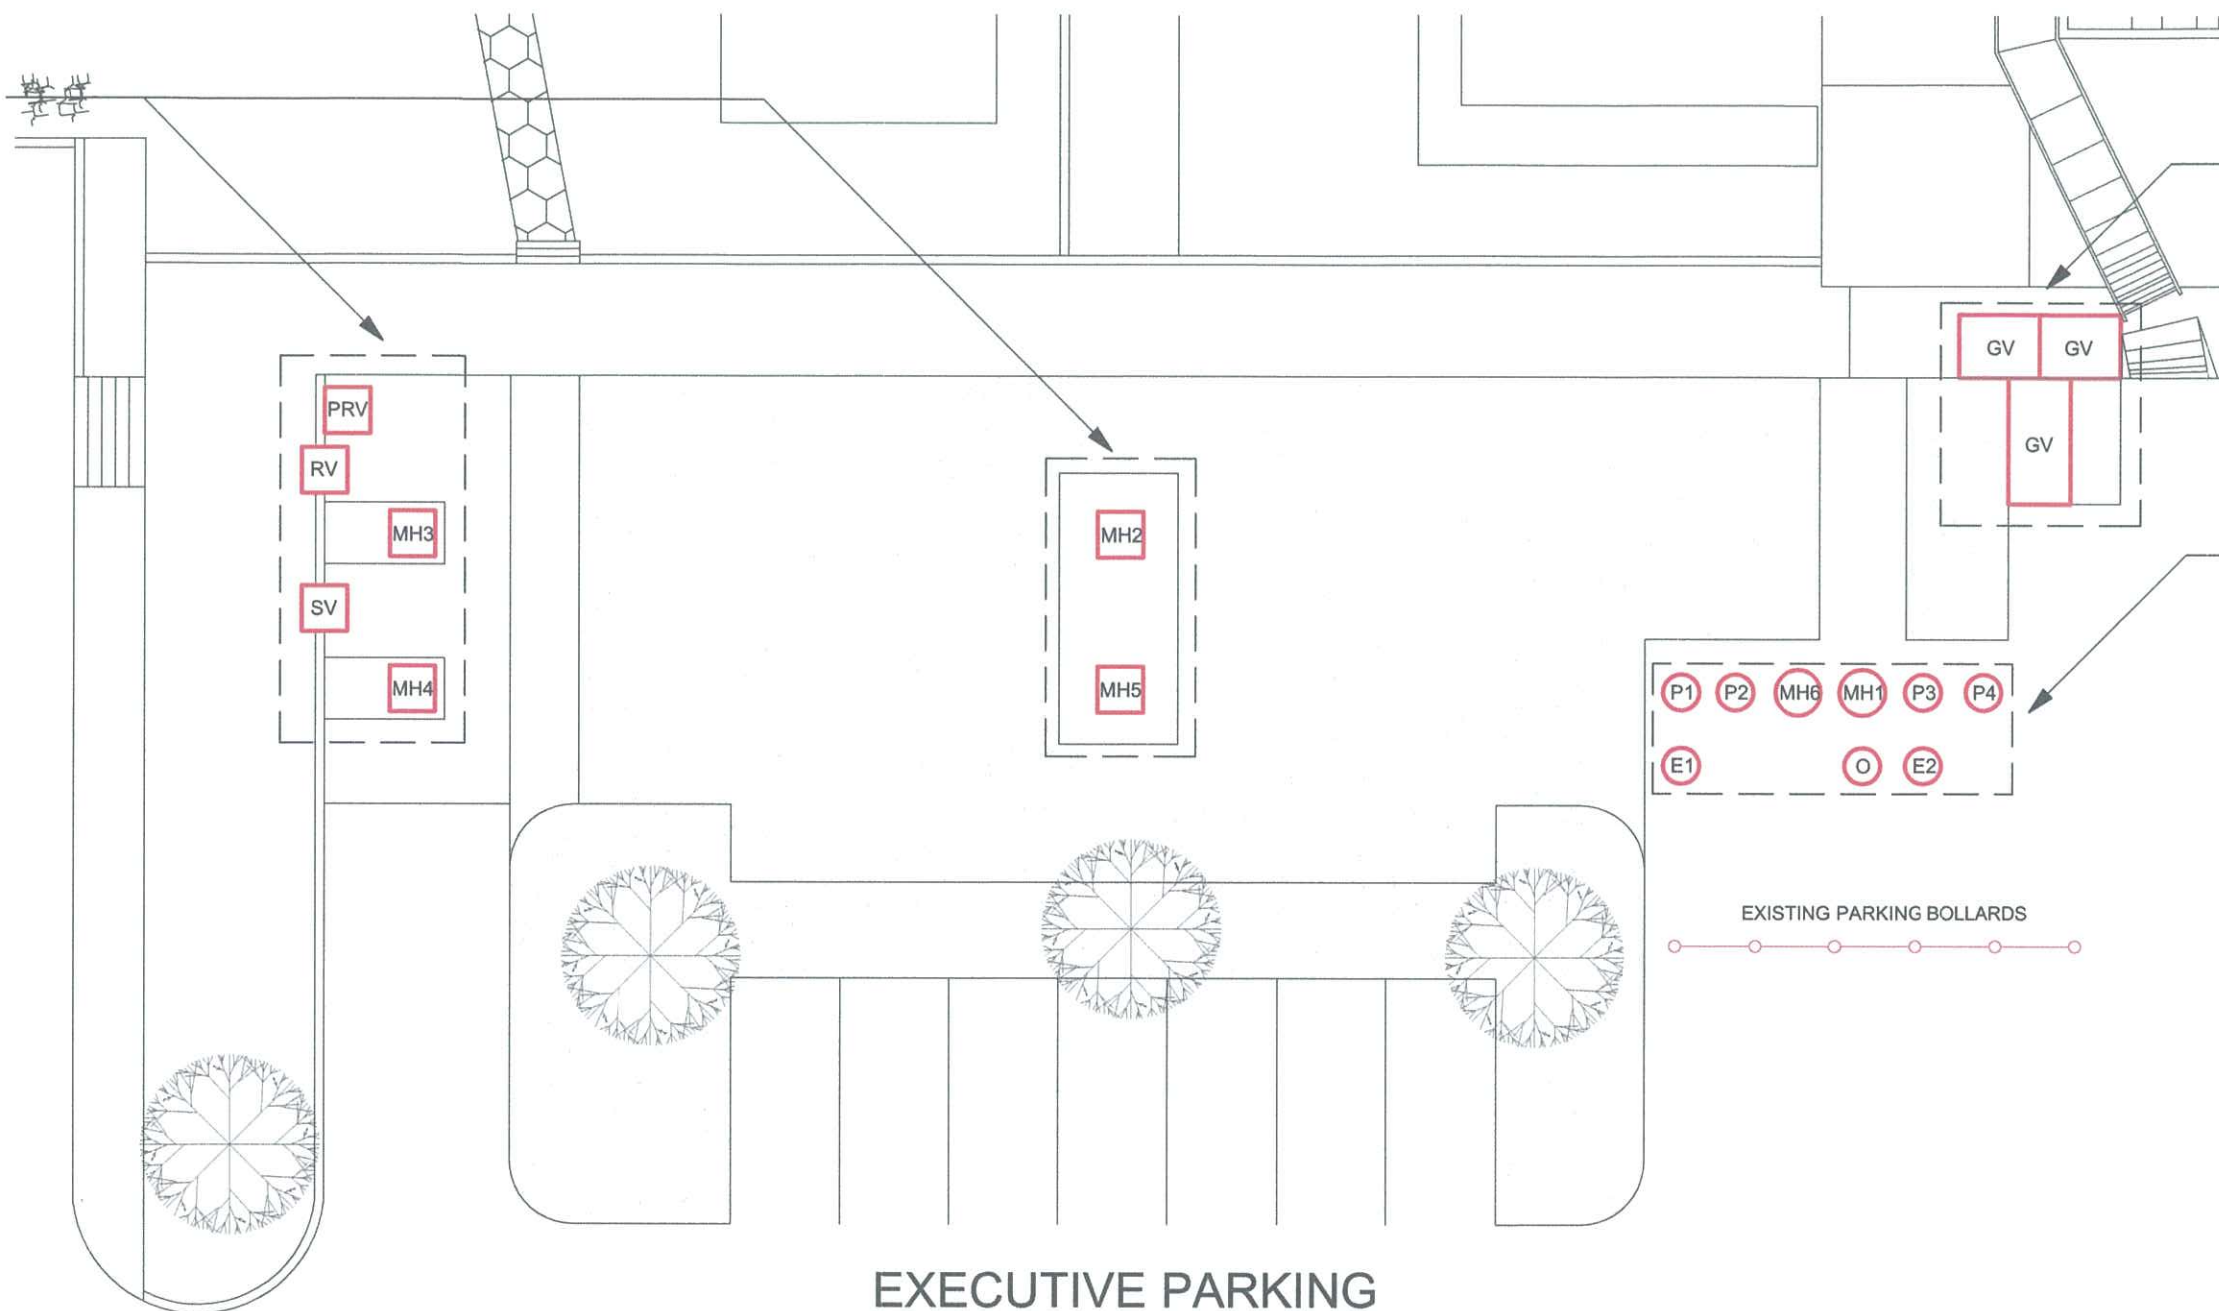

EXECUTIVE PARKING

1
A 2

DETAIL OF DELEGATION CISTERN TANK MANHOLES

SCALE:


1 : 150 M

LEGENDS:


- PRV - PRESSURE RELIEF VALVE
- GV - GATE VALVE
- RV - RELEASE VALVE
- SV - SUPPLY VALVE
- MH - CISTERN TANK MANHOLE COVER
- O - OVER FLOW VALVE (CISTERN TANK)
- P - PUMP
- E - ELECTRICAL




TITLE	DATE	REVISION	VERIFIED BY	RECOMMENDING APPROVAL	APPROVED BY	SHEET NO.
SUPPLY OF LABOR AND MATERIALS FOR THE CLEANING OF CISTERN TANKS AT DELEGATION, POWER HOUSE AND FORUM	09 . 16 . 2022	12 . 21 . 2023	AR. REYNALDO S. MENDOZA JR. BNC SERVICES OFFICER	ENGR. WILSON B. DELOS REYES DIRECTOR, TSD	ATTY. REYNALDO B. PADILLA GENERAL MANAGER	2
LOCATION	AUTOCAD BY	CHECKED BY				A 6
PICC COMPLEX	LOUIE JAY E. GADON AUTOCAD OPERATOR	ENGR. EDISON T. AURELIO ASSISTANT DIRECTOR, BSD-TSD	MR. ROBERTO A. GARCIA DEPUTY GENERAL MANAGER			

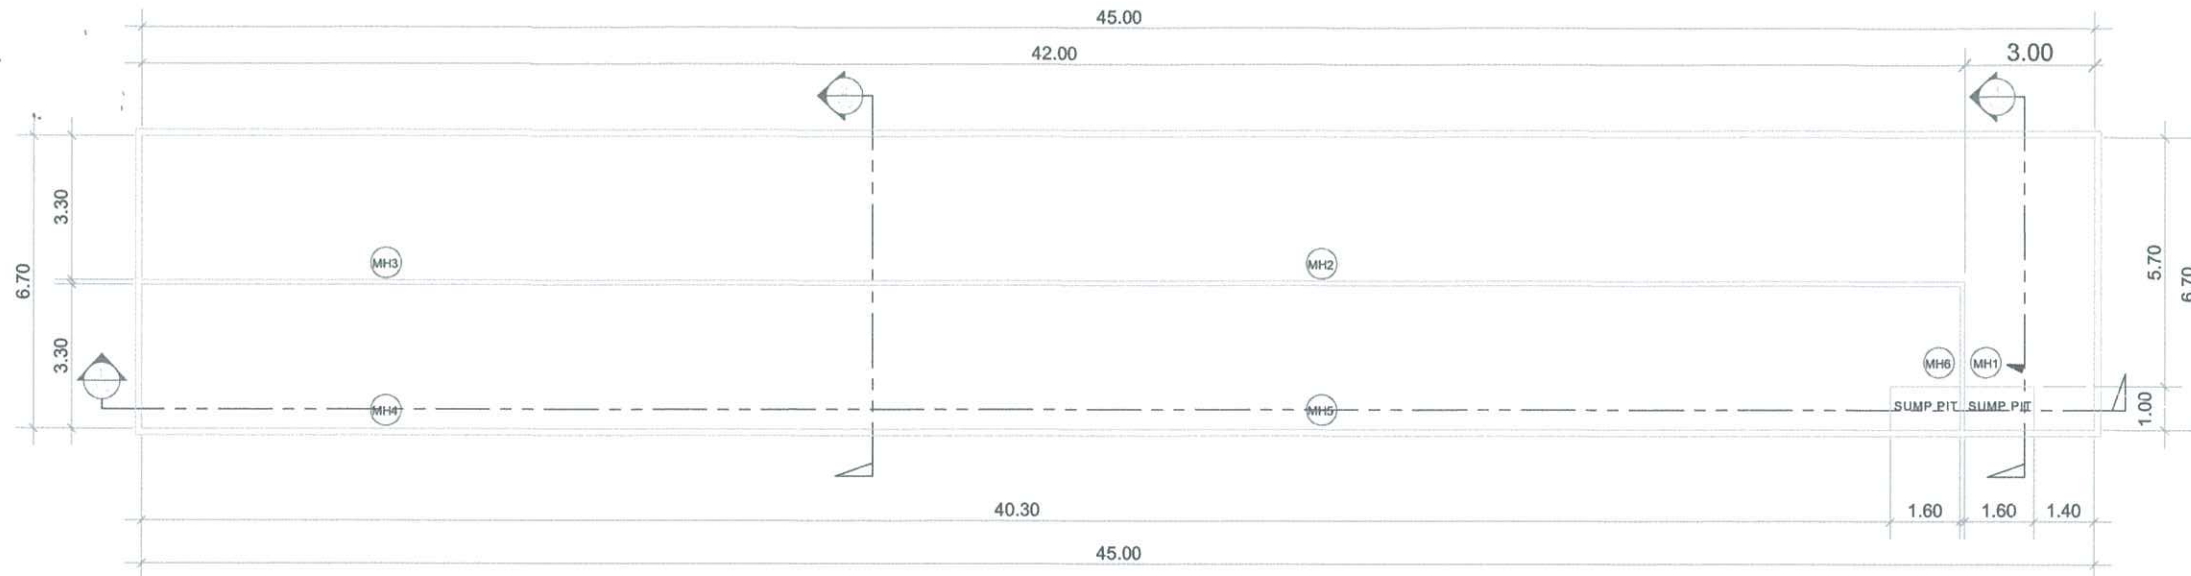


1A FLOOR PLAN
A 2 SCALE: 1 : 200 M

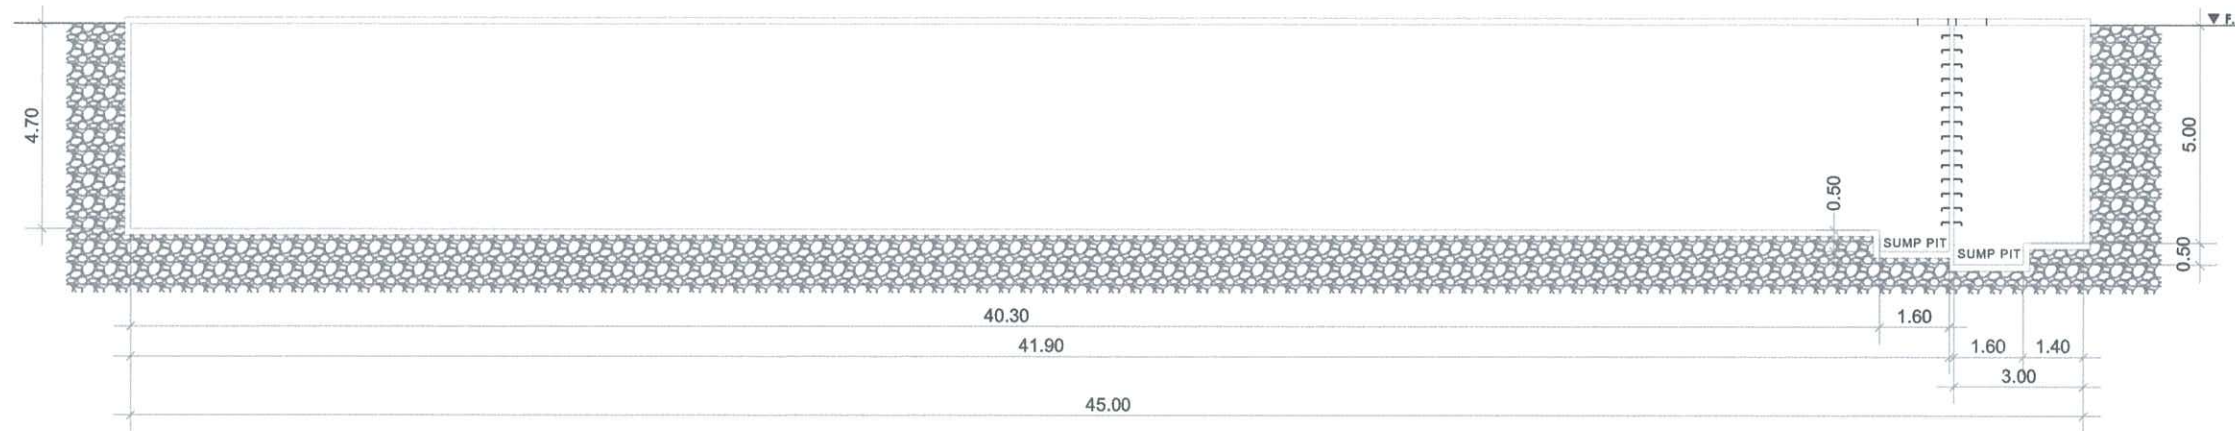


1B SECTION 1
A 3 SCALE: 1 : 200 M

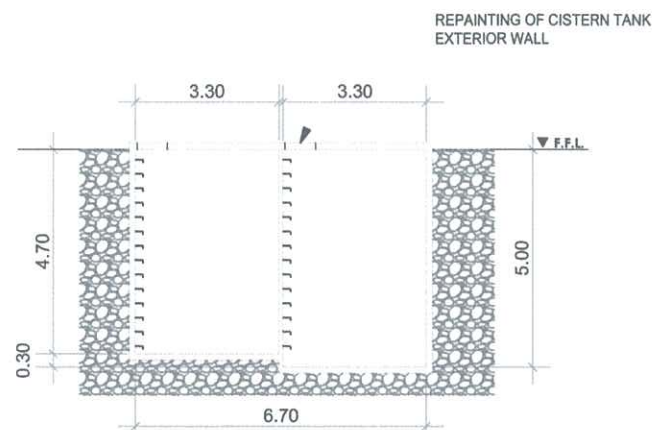

1C SECTION 2
A 3 SCALE: 1 : 200 M

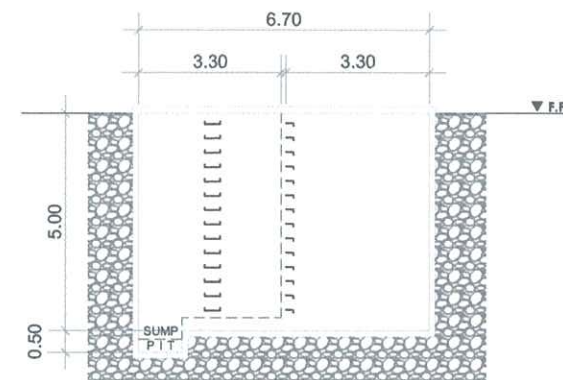

1D SECTION 3
A 3 SCALE: 1 : 200 M

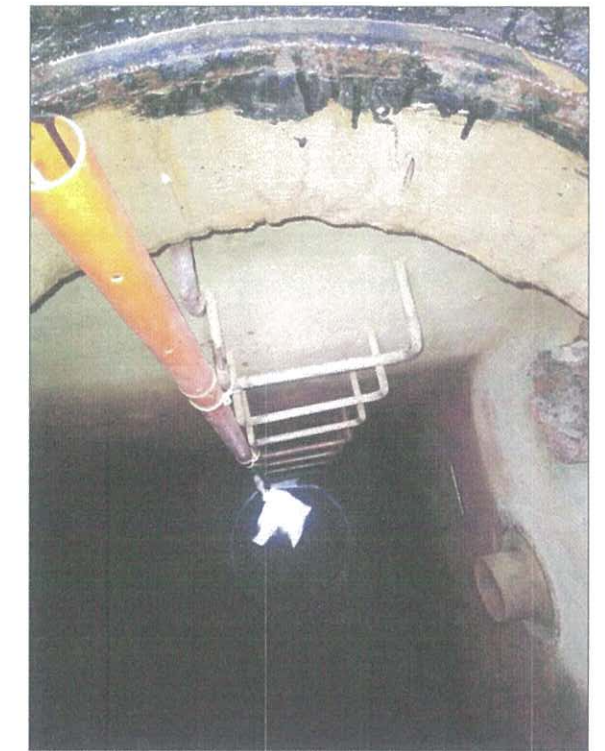


TYPICAL MANHOLE WITH ACCESS LADDER




1 DELEGATION CISTERN TANK
A 3 SCALE: 1 : 200 M




TITLE	DATE	REVISION	VERIFIED BY	RECOMMENDING APPROVAL	APPROVED BY	SHEET NO.
SUPPLY OF LABOR AND MATERIALS FOR THE CLEANING OF CISTERN TANKS AT DELEGATION, POWER HOUSE AND FORUM	09 . 16 . 2022	12 . 21 . 2023	AR. REYNALDO B. MENDOZA JR. (BLDG. SERVICES OFFICER)	ENGR. WILSON B. DELOS REYES DIRECTOR, TSD	ATTY. RENATO B. PADILLA GENERAL MANAGER	3
LOCATION	AUTOCAD BY	CHECKED BY				A 6
PICC COMPLEX	LOUIE JAY E. GADON AUTOCAD OPERATOR	ENGR. EDISON I. AURELIO ASSISTANT DIRECTOR, BSD-TSD		MR. ROBERTO A. GARCIA DEPUTY GENERAL MANAGER		

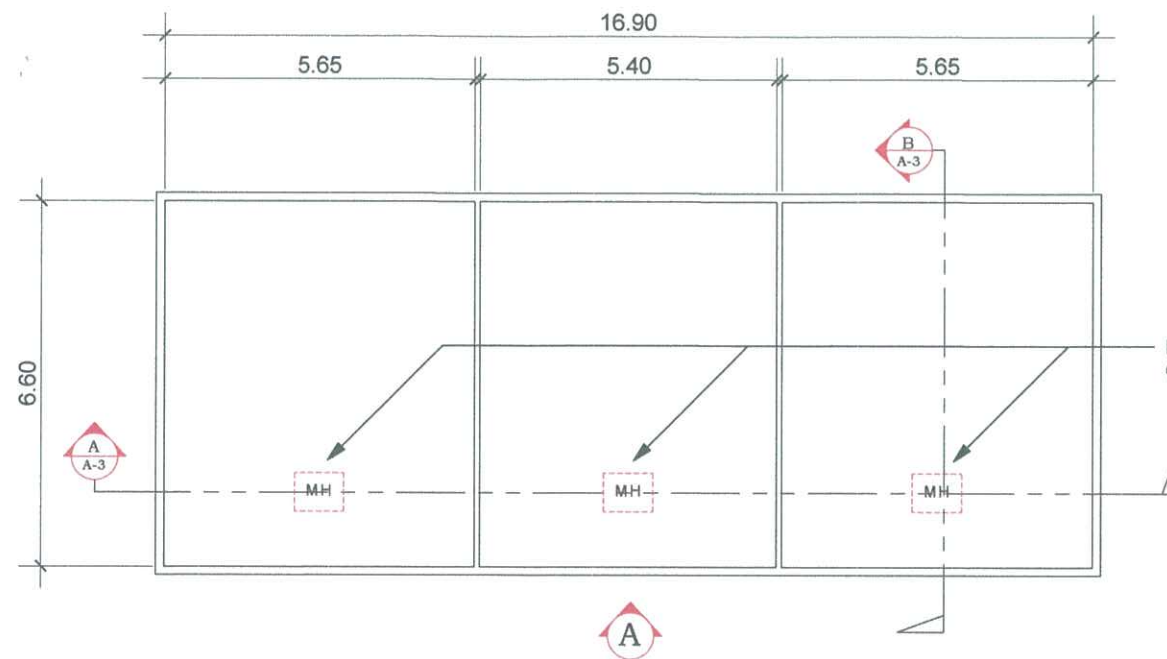


1A FLOOR PLAN
SCALE: 1 : 150 M

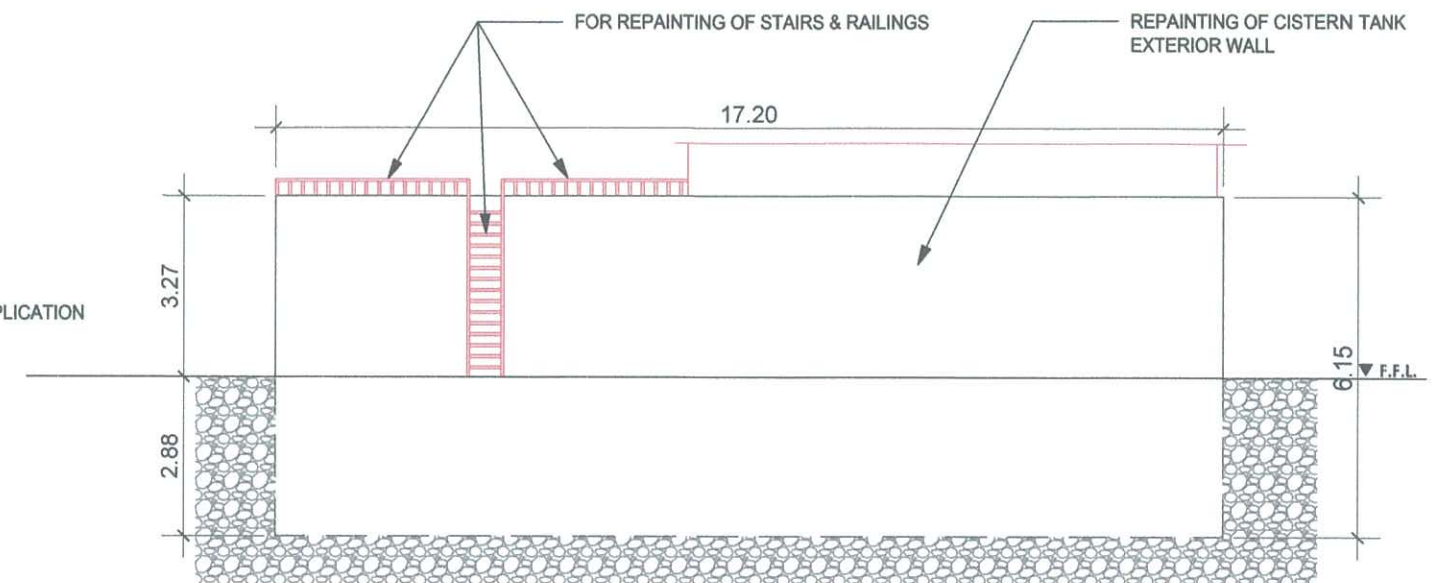

1B ELEVATION A
SCALE: 1 : 150 M

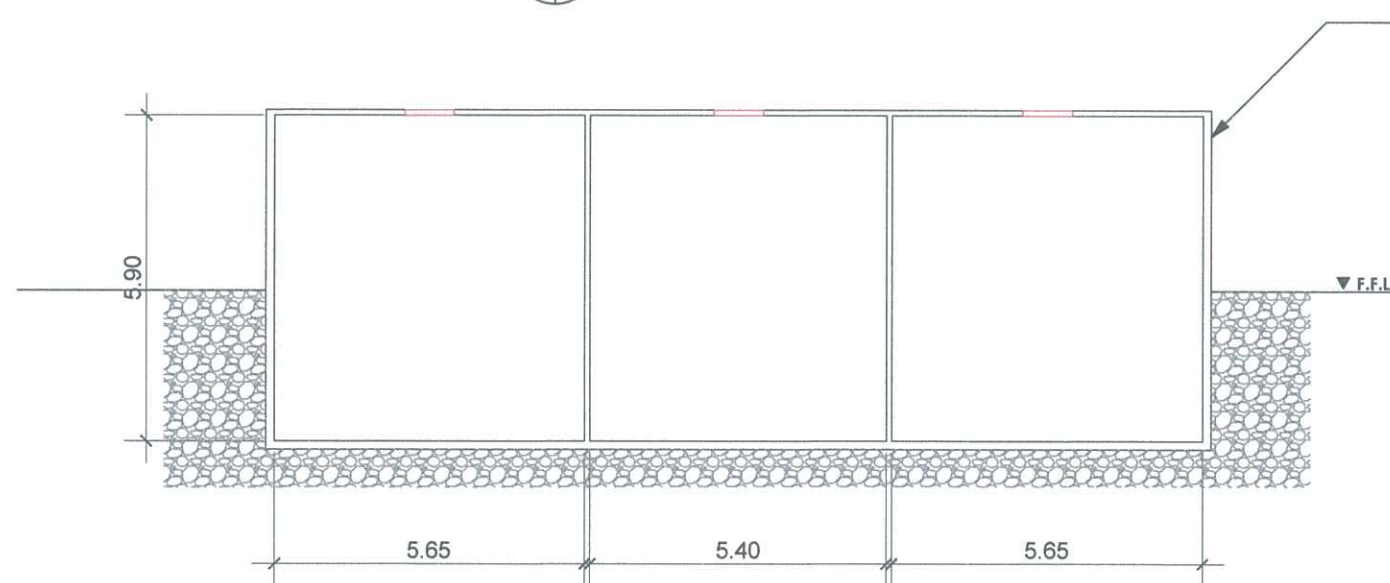

1C SECTION A
SCALE: 1 : 150 M

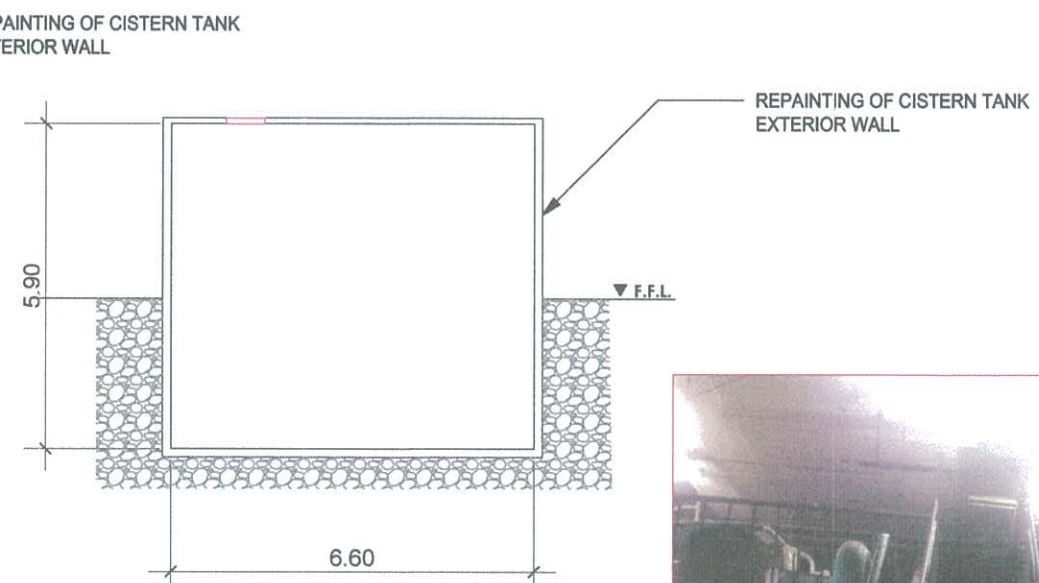


1D SECTION B
SCALE: 1 : 150 M

1 POWER HOUSE CISTERN TANK
SCALE: 1 : 150 M




TITLE	DATE	REVISION	VERIFIED BY	RECOMMENDING APPROVAL	APPROVED BY	SHEET NO.
SUPPLY OF LABOR AND MATERIALS FOR THE CLEANING OF CISTERN TANKS AT DELEGATION, POWER HOUSE AND FORUM	09 . 16 . 2022	12 . 21 . 2023	AR. REYNALDO B. MENDOZA JR. BLDG. SERVICES OFFICER	ENGR. WILSON B. DELOS REYES DIRECTOR, T&E	ATTY. RENATO B. PADILLA GENERAL MANAGER	4
LOCATION	AUTOCAD BY	CHECKED BY				A 6
PICC COMPLEX	LOUIE JAY E. GADON AUTOCAD OPERATOR	ENGR. EDISON T. AURELIO ASSISTANT DIRECTOR, BSD-TSD	MR. ROBERTO A. GARCIA DEPUTY GENERAL MANAGER			

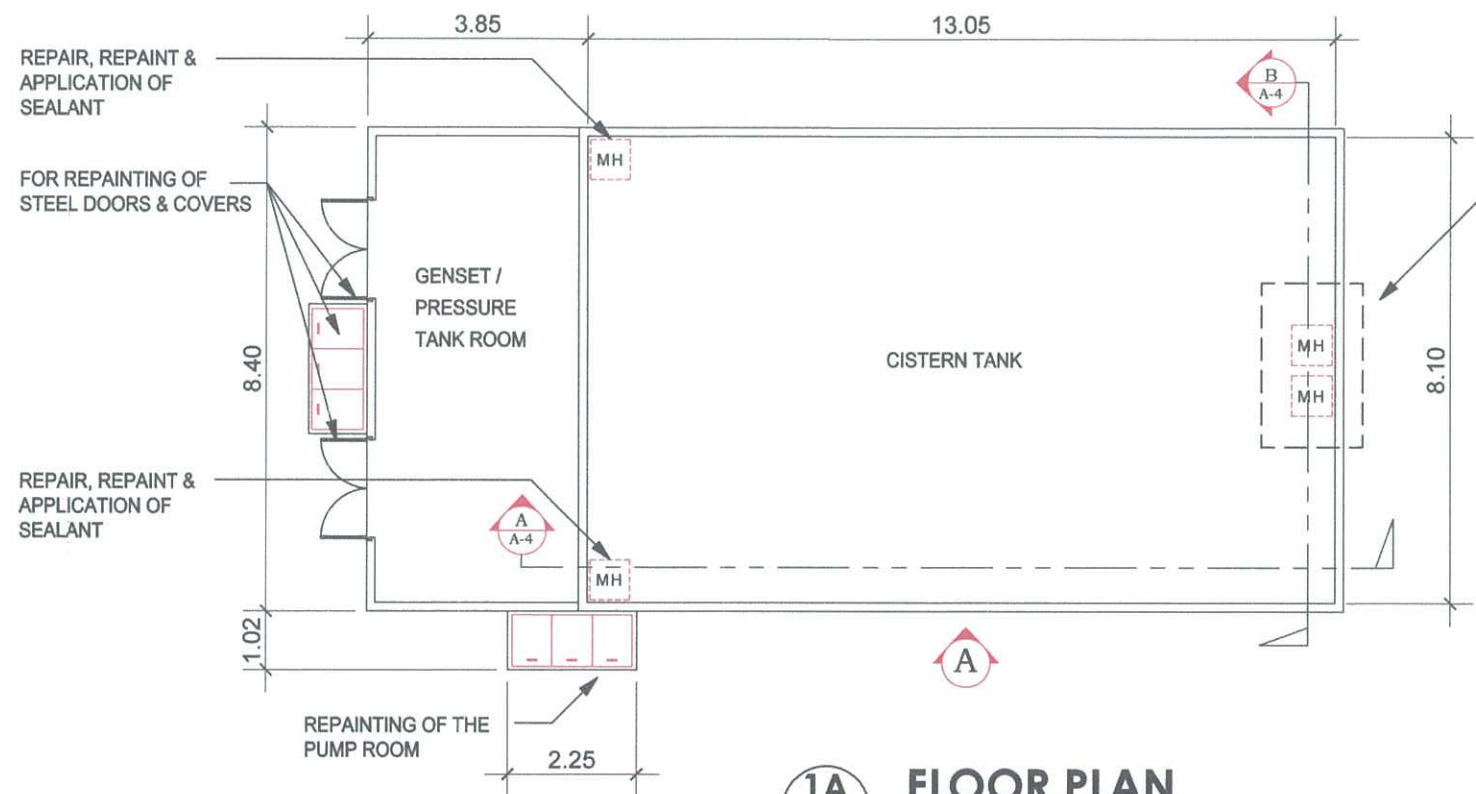


1A FLOOR PLAN
SCALE: 1 : 150 M


REPAIR, REPAINT &
APPLICATION OF
SEALANT

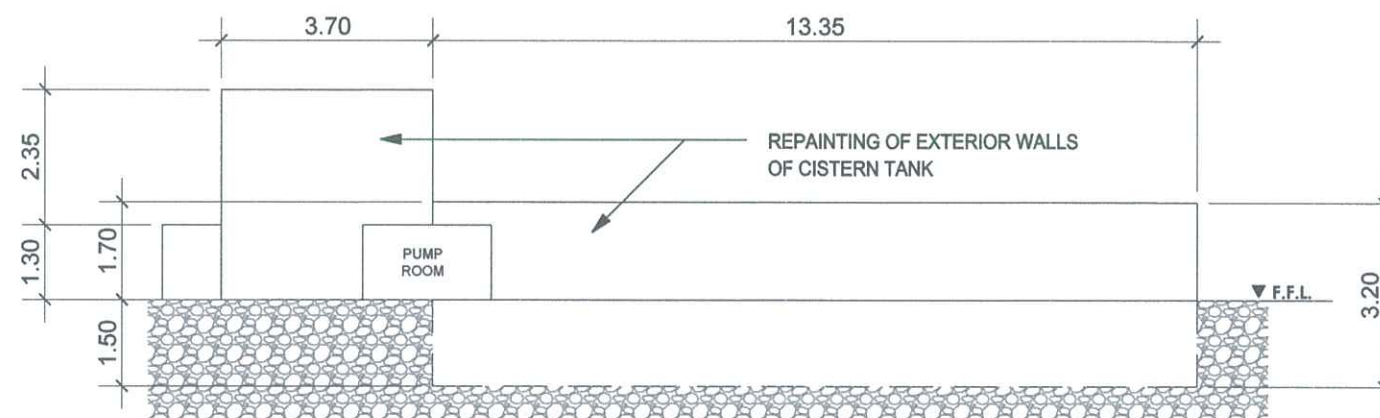

1B ELEVATION A
SCALE: 1 : 150 M

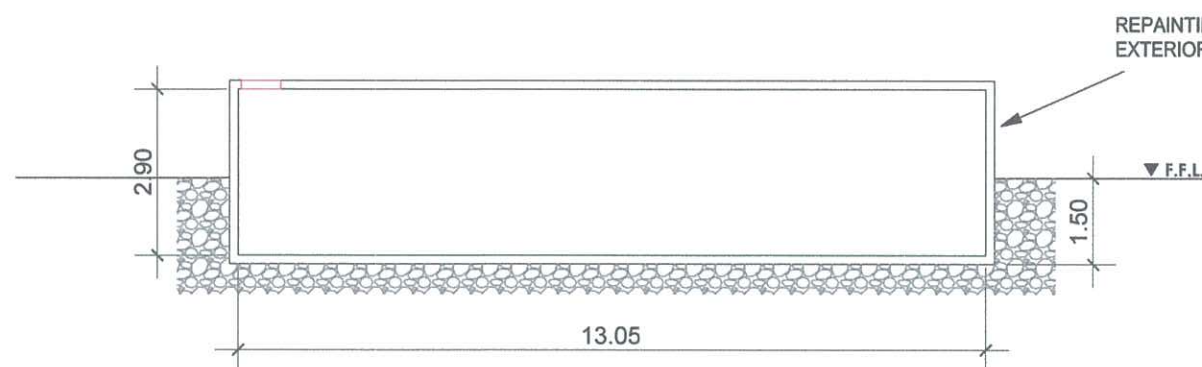

1C SECTION A
SCALE: 1 : 150 M

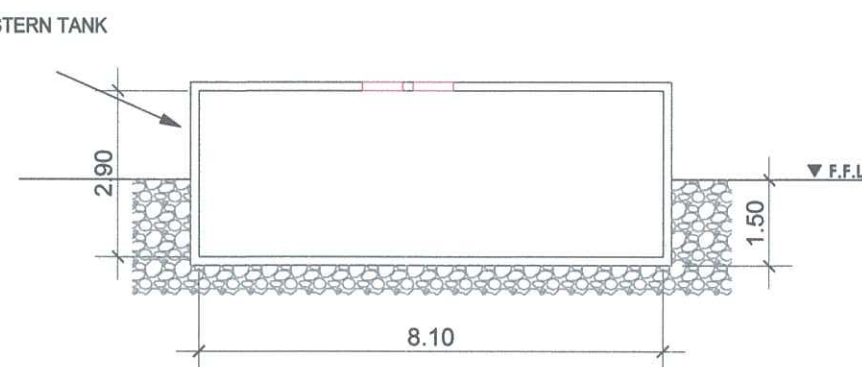

1D SECTION B
SCALE: 1 : 150 M

1 FORUM CISTERN TANK
SCALE: 1 : 150 M




TITLE	DATE	REVISION	VERIFIED BY	RECOMMENDING APPROVAL	APPROVED BY	SHEET NO.
SUPPLY OF LABOR AND MATERIALS FOR THE CLEANING OF CISTERN TANKS AT DELEGATION, POWER HOUSE AND FORUM	09 . 16 . 2022	12 . 21 . 2023	AR. REYNALDO B. MENDOZA JR. BLDG. SERVICES OFFICER	ENGR. WILSON B. DELOS REYES DIRECTOR, TSD	ATTY. RENATO B. PADILLA GENERAL MANAGER	5
LOCATION	AUTOCAD BY	CHECKED BY				A 6
PICC COMPLEX	LOUIE JAY E. GADON AUTOCAD OPERATOR	ENGR. EDISON T. AURELIO ASSISTANT DIRECTOR, BSD-TSD	MR. ROBERTO A. GARCIA DEPUTY GENERAL MANAGER			

**We are undertaking
Major repairs to
provide you with
better facilities and
service**

**SORRY FOR THE
INCONVENIENCE**



**SAFETY SIGNAGE, SAME AS PICC
STANDARD SIGNAGE, 22" x 32"
PRINTED IN SINTRA BOARD**

	TITLE	DATE	REVISION	VERIFIED BY	RECOMMENDING APPROVAL	APPROVED BY	SHEET NO.
	SUPPLY OF LABOR AND MATERIALS FOR THE CLEANING OF CISTERN TANKS AT DELEGATION, POWER HOUSE AND FORUM	09 . 16 . 2022	12 . 21 . 2023	AR. REYNALDO B. MENDOZA JR. BLDG. SERVICES OFFICER	ENGR. WILSON B. DELOS REYES DIRECTOR, TSD	ATTY. RENATO B. PADILLA GENERAL MANAGER	6
	LOCATION	AUTOCAD BY	CHECKED BY				A 6
	PICC COMPLEX	LOUIE JAY E. GADON AUTOCAD OPERATOR	ENGR. EDISON T. AURELIO ASSISTANT DIRECTOR, BSD-TSD		MR. ROBERTO A. GARCIA DEPUTY GENERAL MANAGER		